



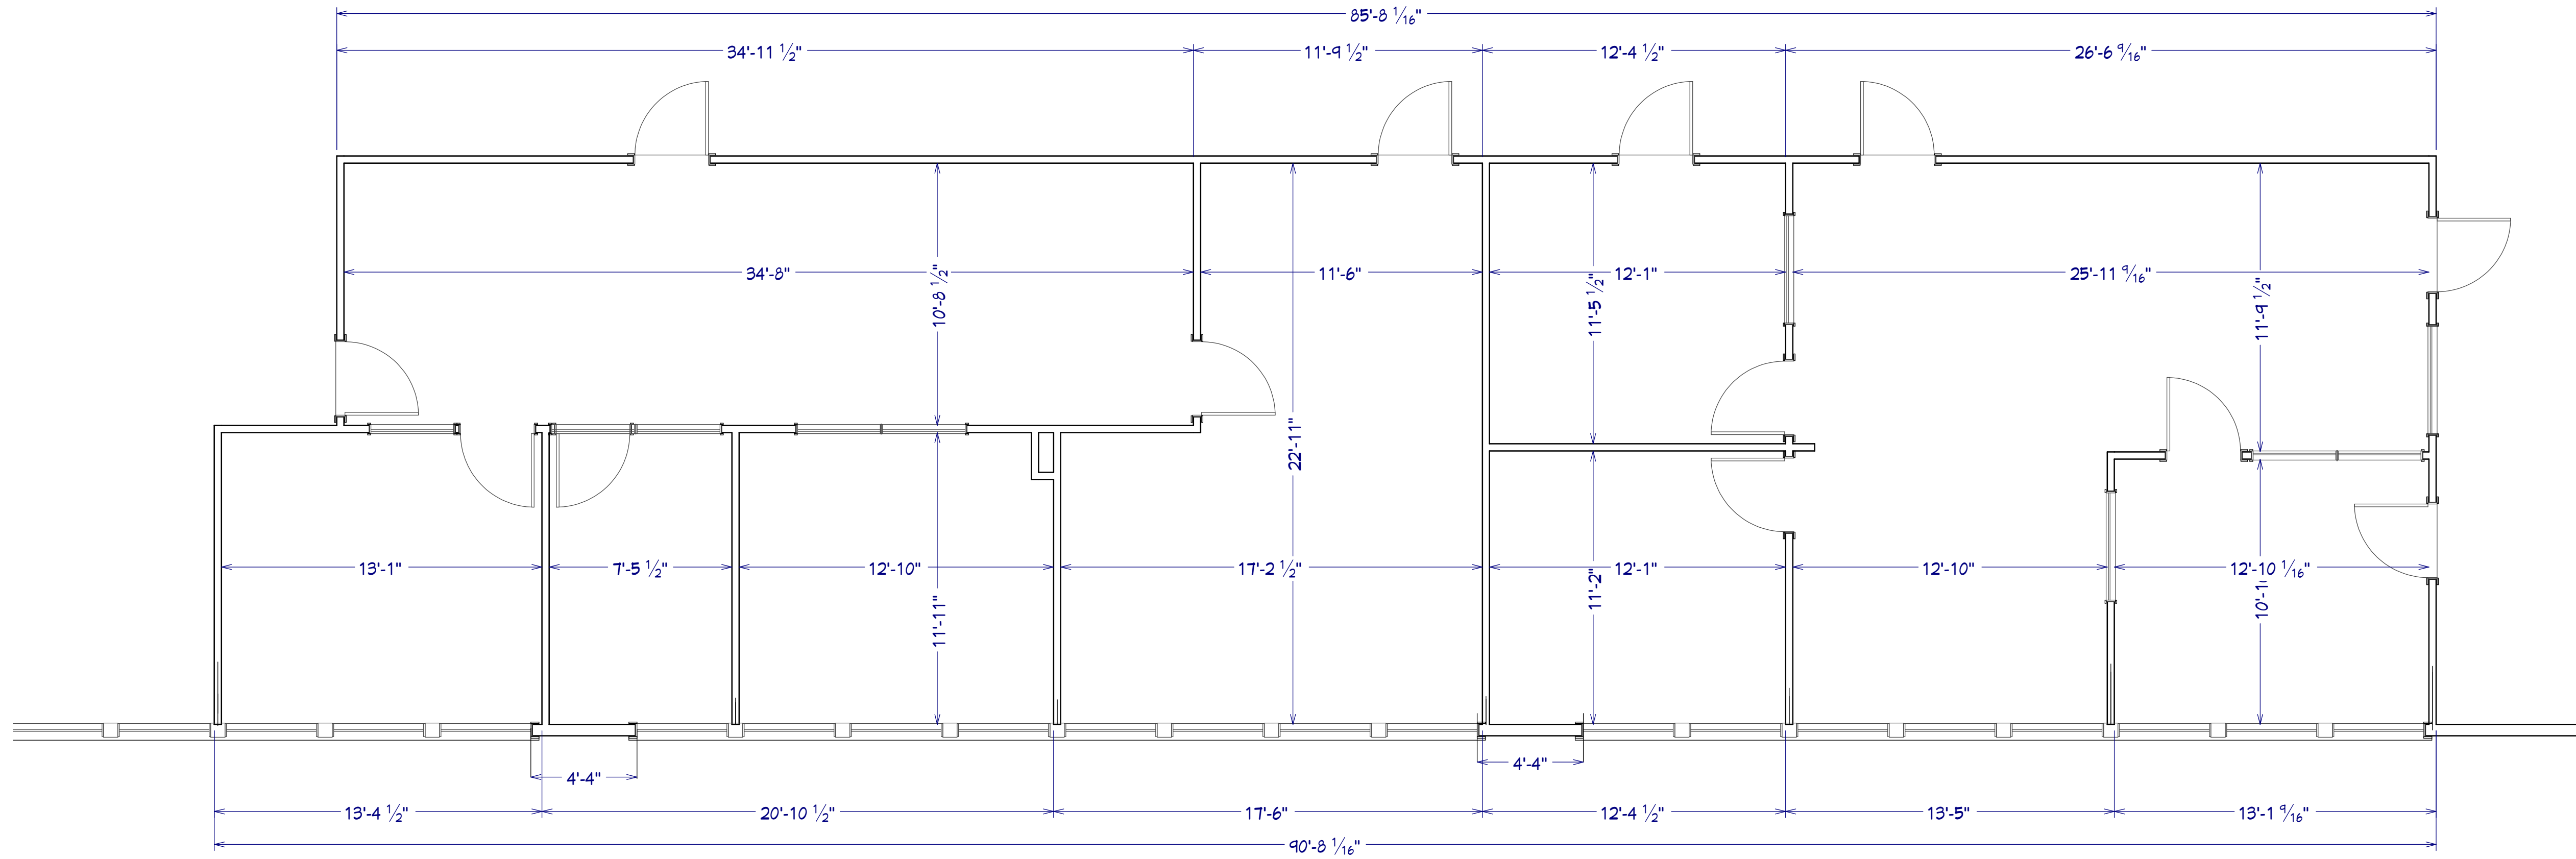

(E) FLOOR PLAN
1/4" = 1'-0"

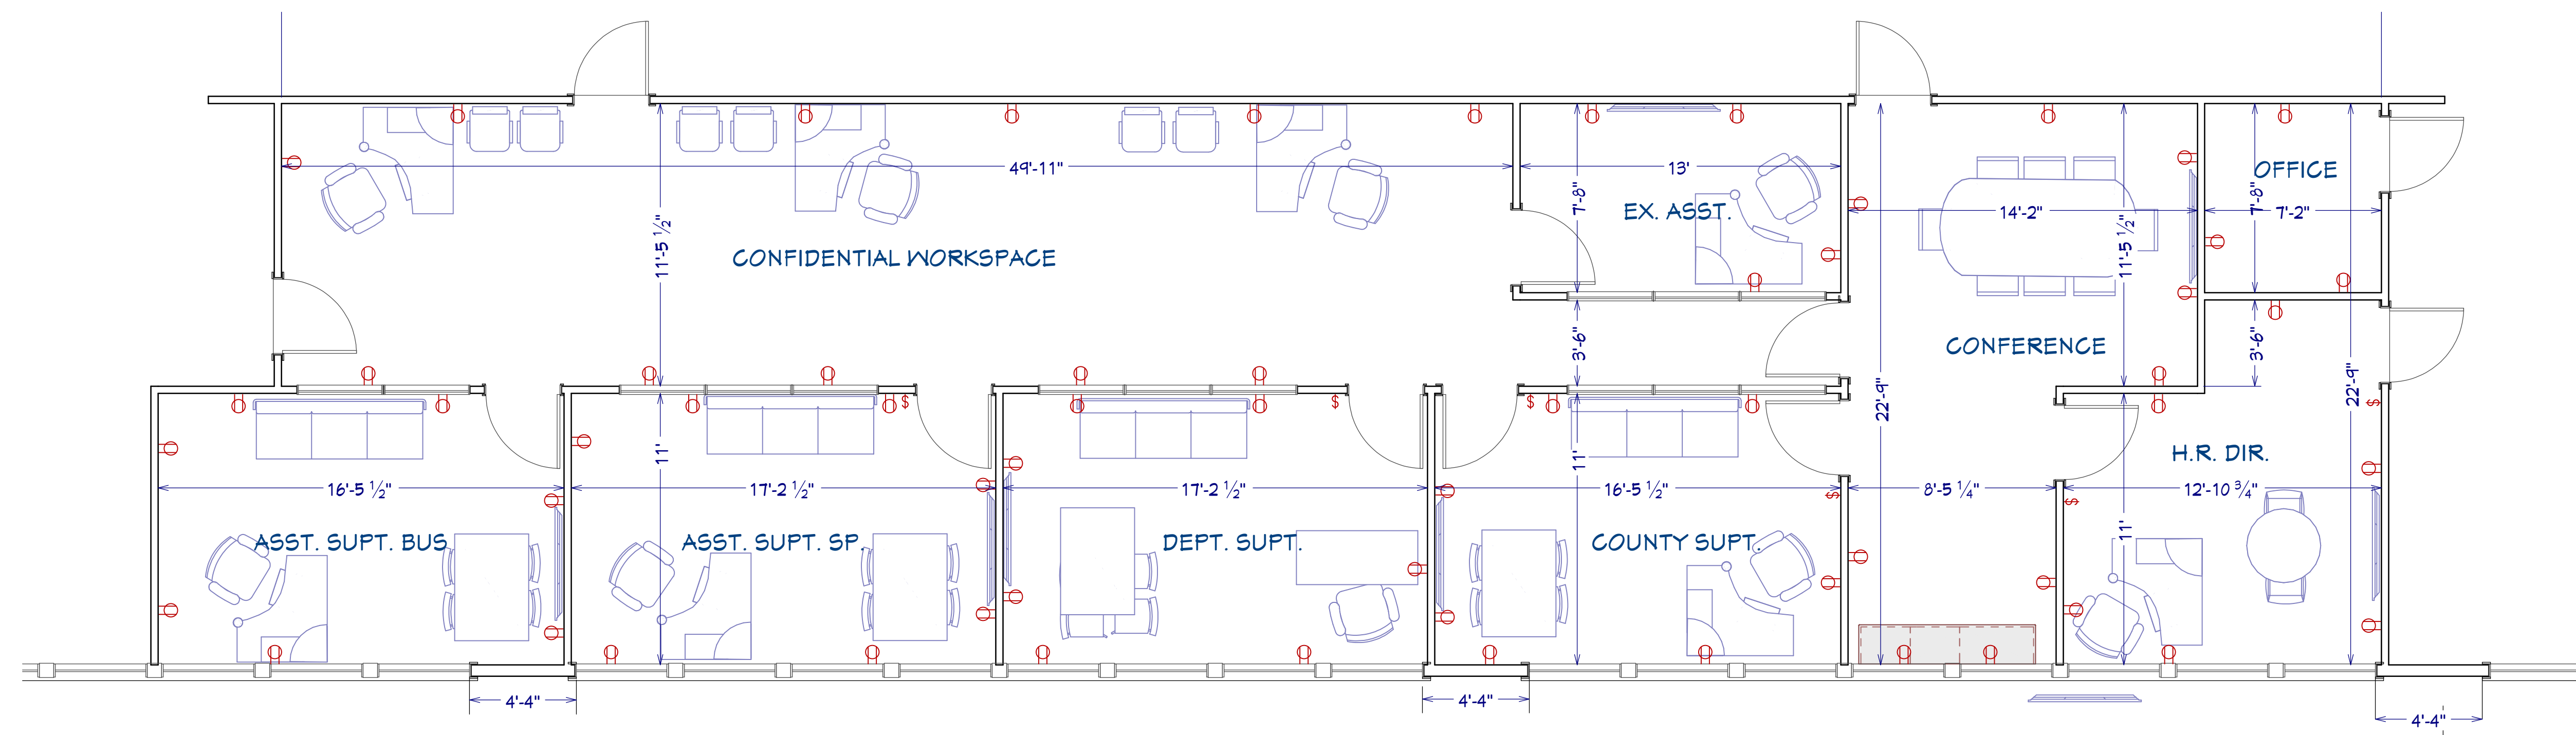

(F) FLOOR PLAN
1/4" = 1'-0"

SUGGESTED ELECTRICAL SCHEDULE		
2D SYMBOL	DESCRIPTION	COMMENTS
	DUPLEX	
	SINGLE POLE SWITCH	FOR OVERHEAD LIGHTING

PAGES	
LABEL	TITLE
A1	PROJECT OVERVIEW
A2	PERSPECTIVE VIEWS
A3	PERSPECTIVE VIEWS

REVISION TABLE

NUMBER	DATE	REVISOR	DESCRIPTION

HUMBOLDT COUNTY OFFICE OF EDUCATION

901 MYRTLE AVE.
EUREKA, CA 95501-1219

Project Overview

DRAWINGS PROVIDED BY:

TOM HINZ
5928 STOVER ROAD
BLUE LAKE, CA 95525
PHONE: 707-418-0134
EMAIL: thinz@gmail.com

SCALE @ 24" X 36"


REVISIONS	NO.

A1


HCOE 1.2
9/14/2024



(P) PERSPECTIVE VIEW
N.T.S.

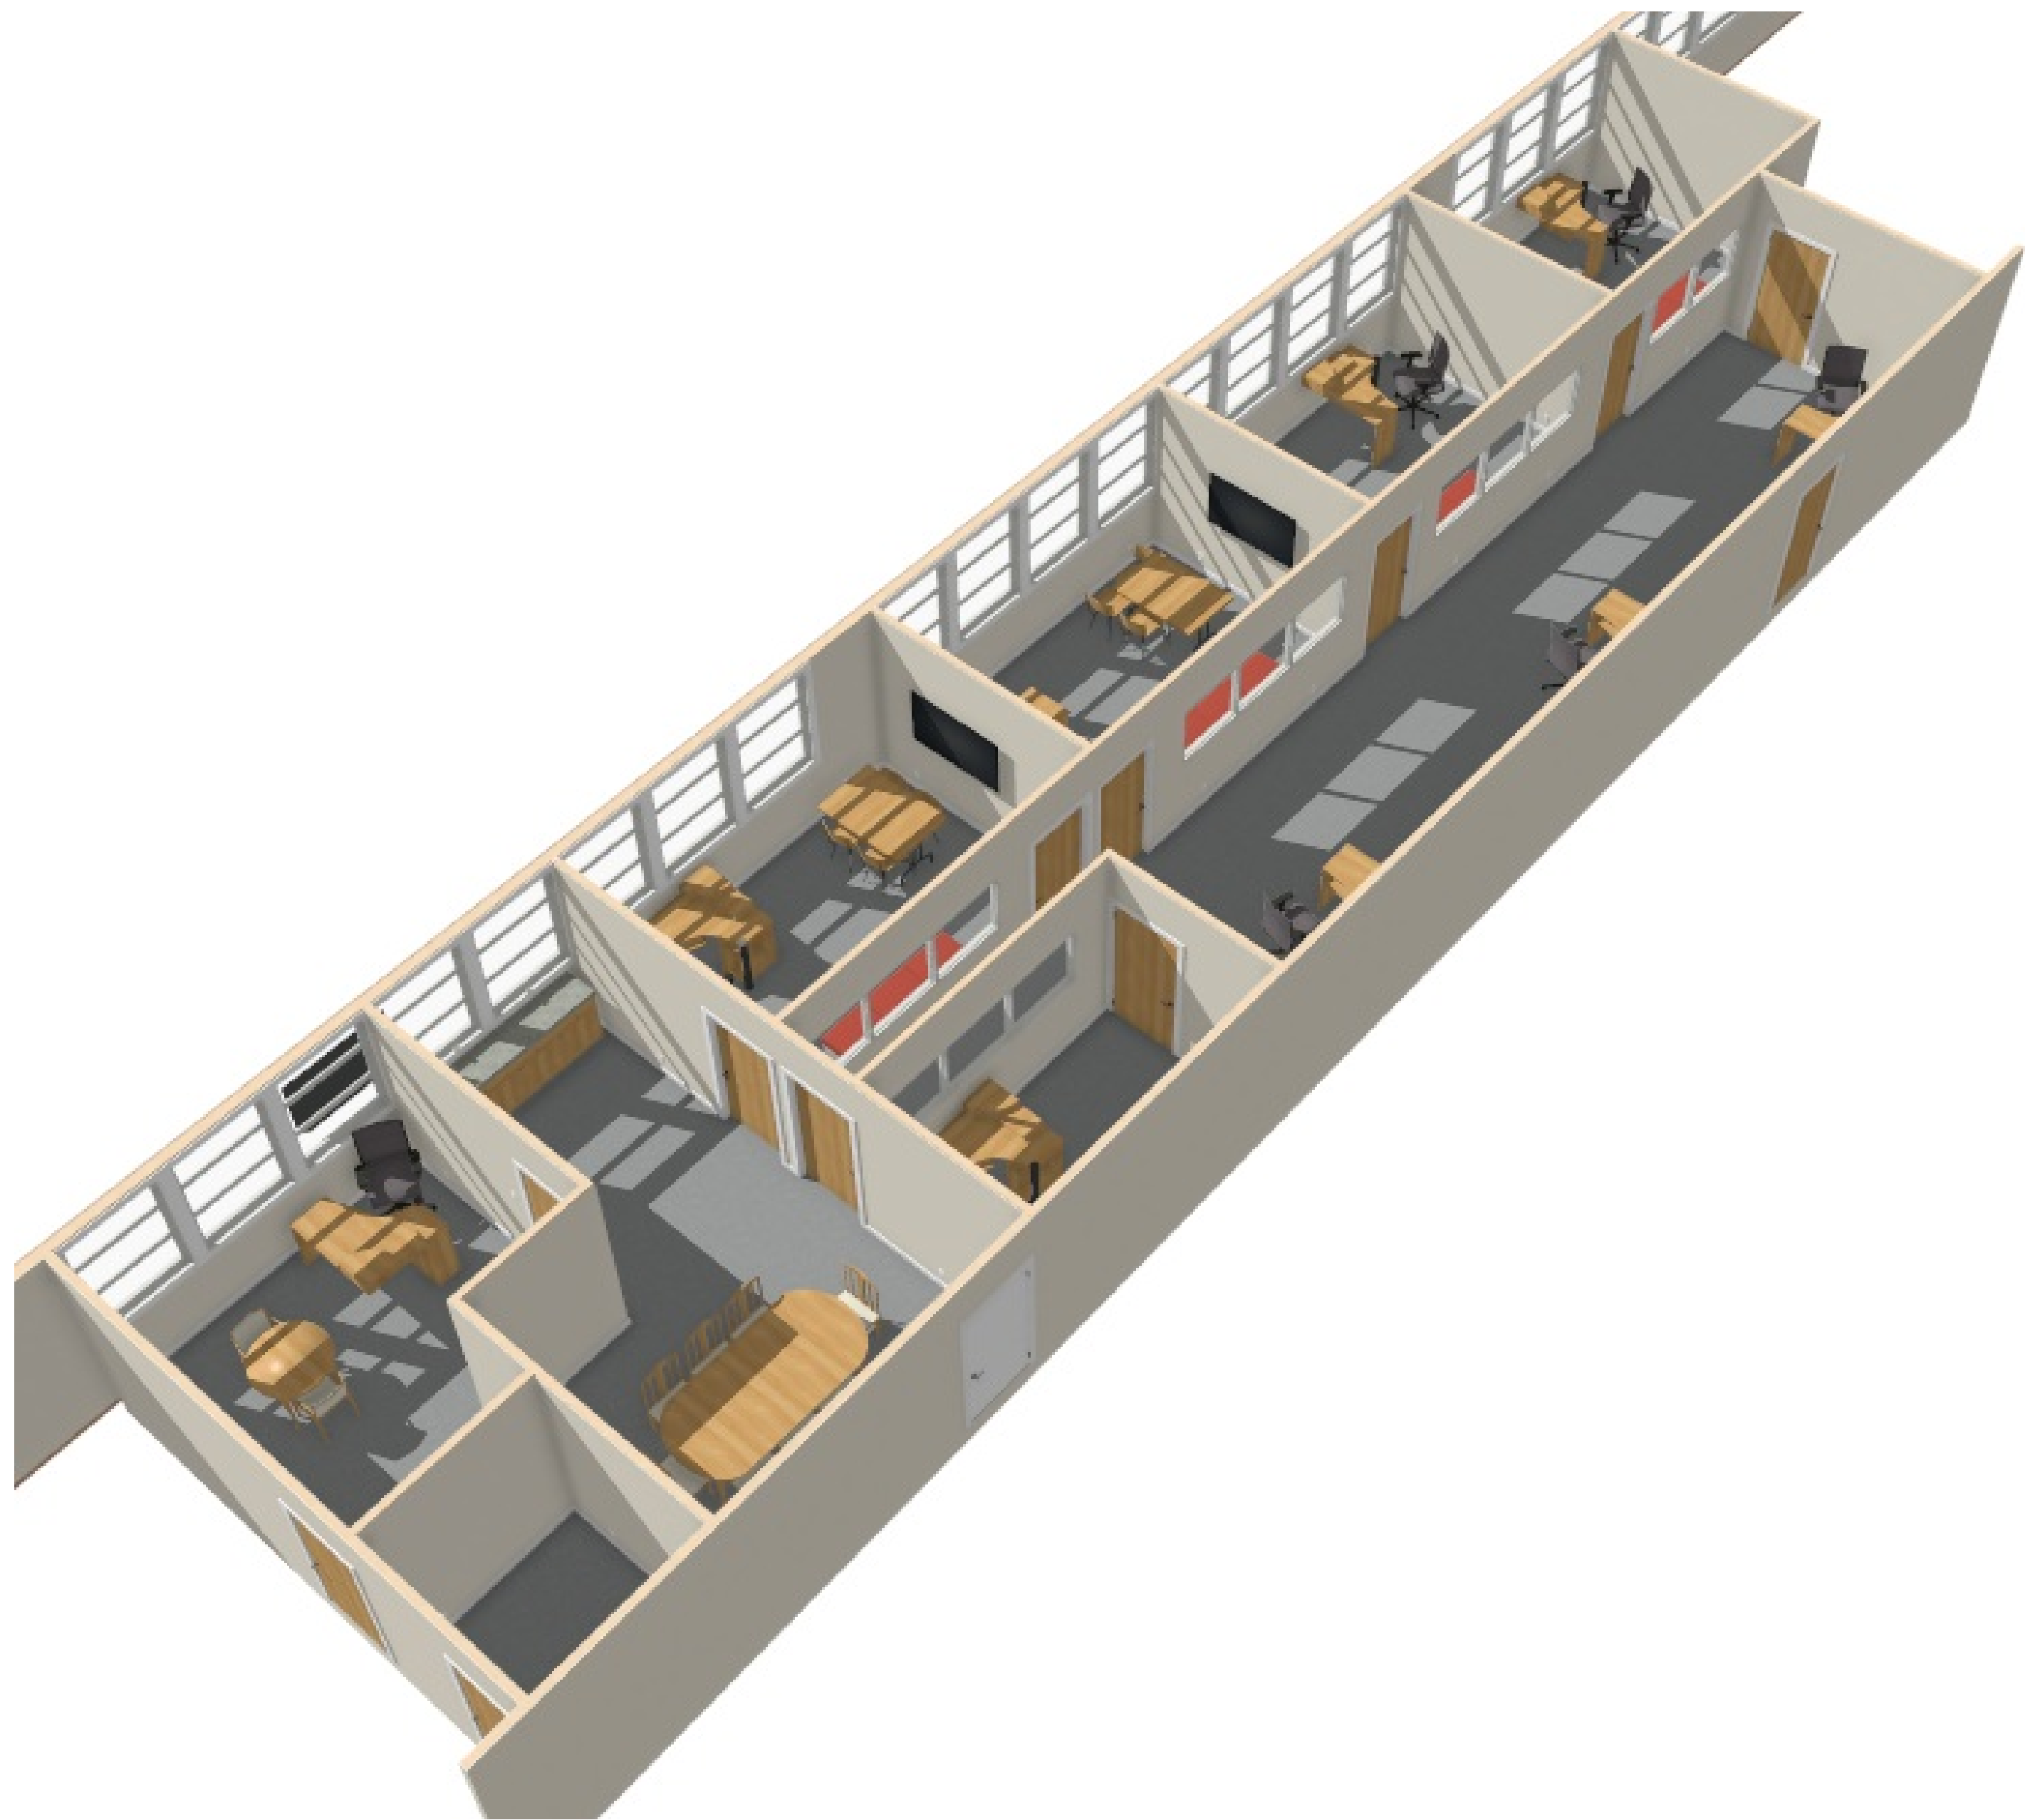

(P) PERSPECTIVE VIEW
N.T.S.

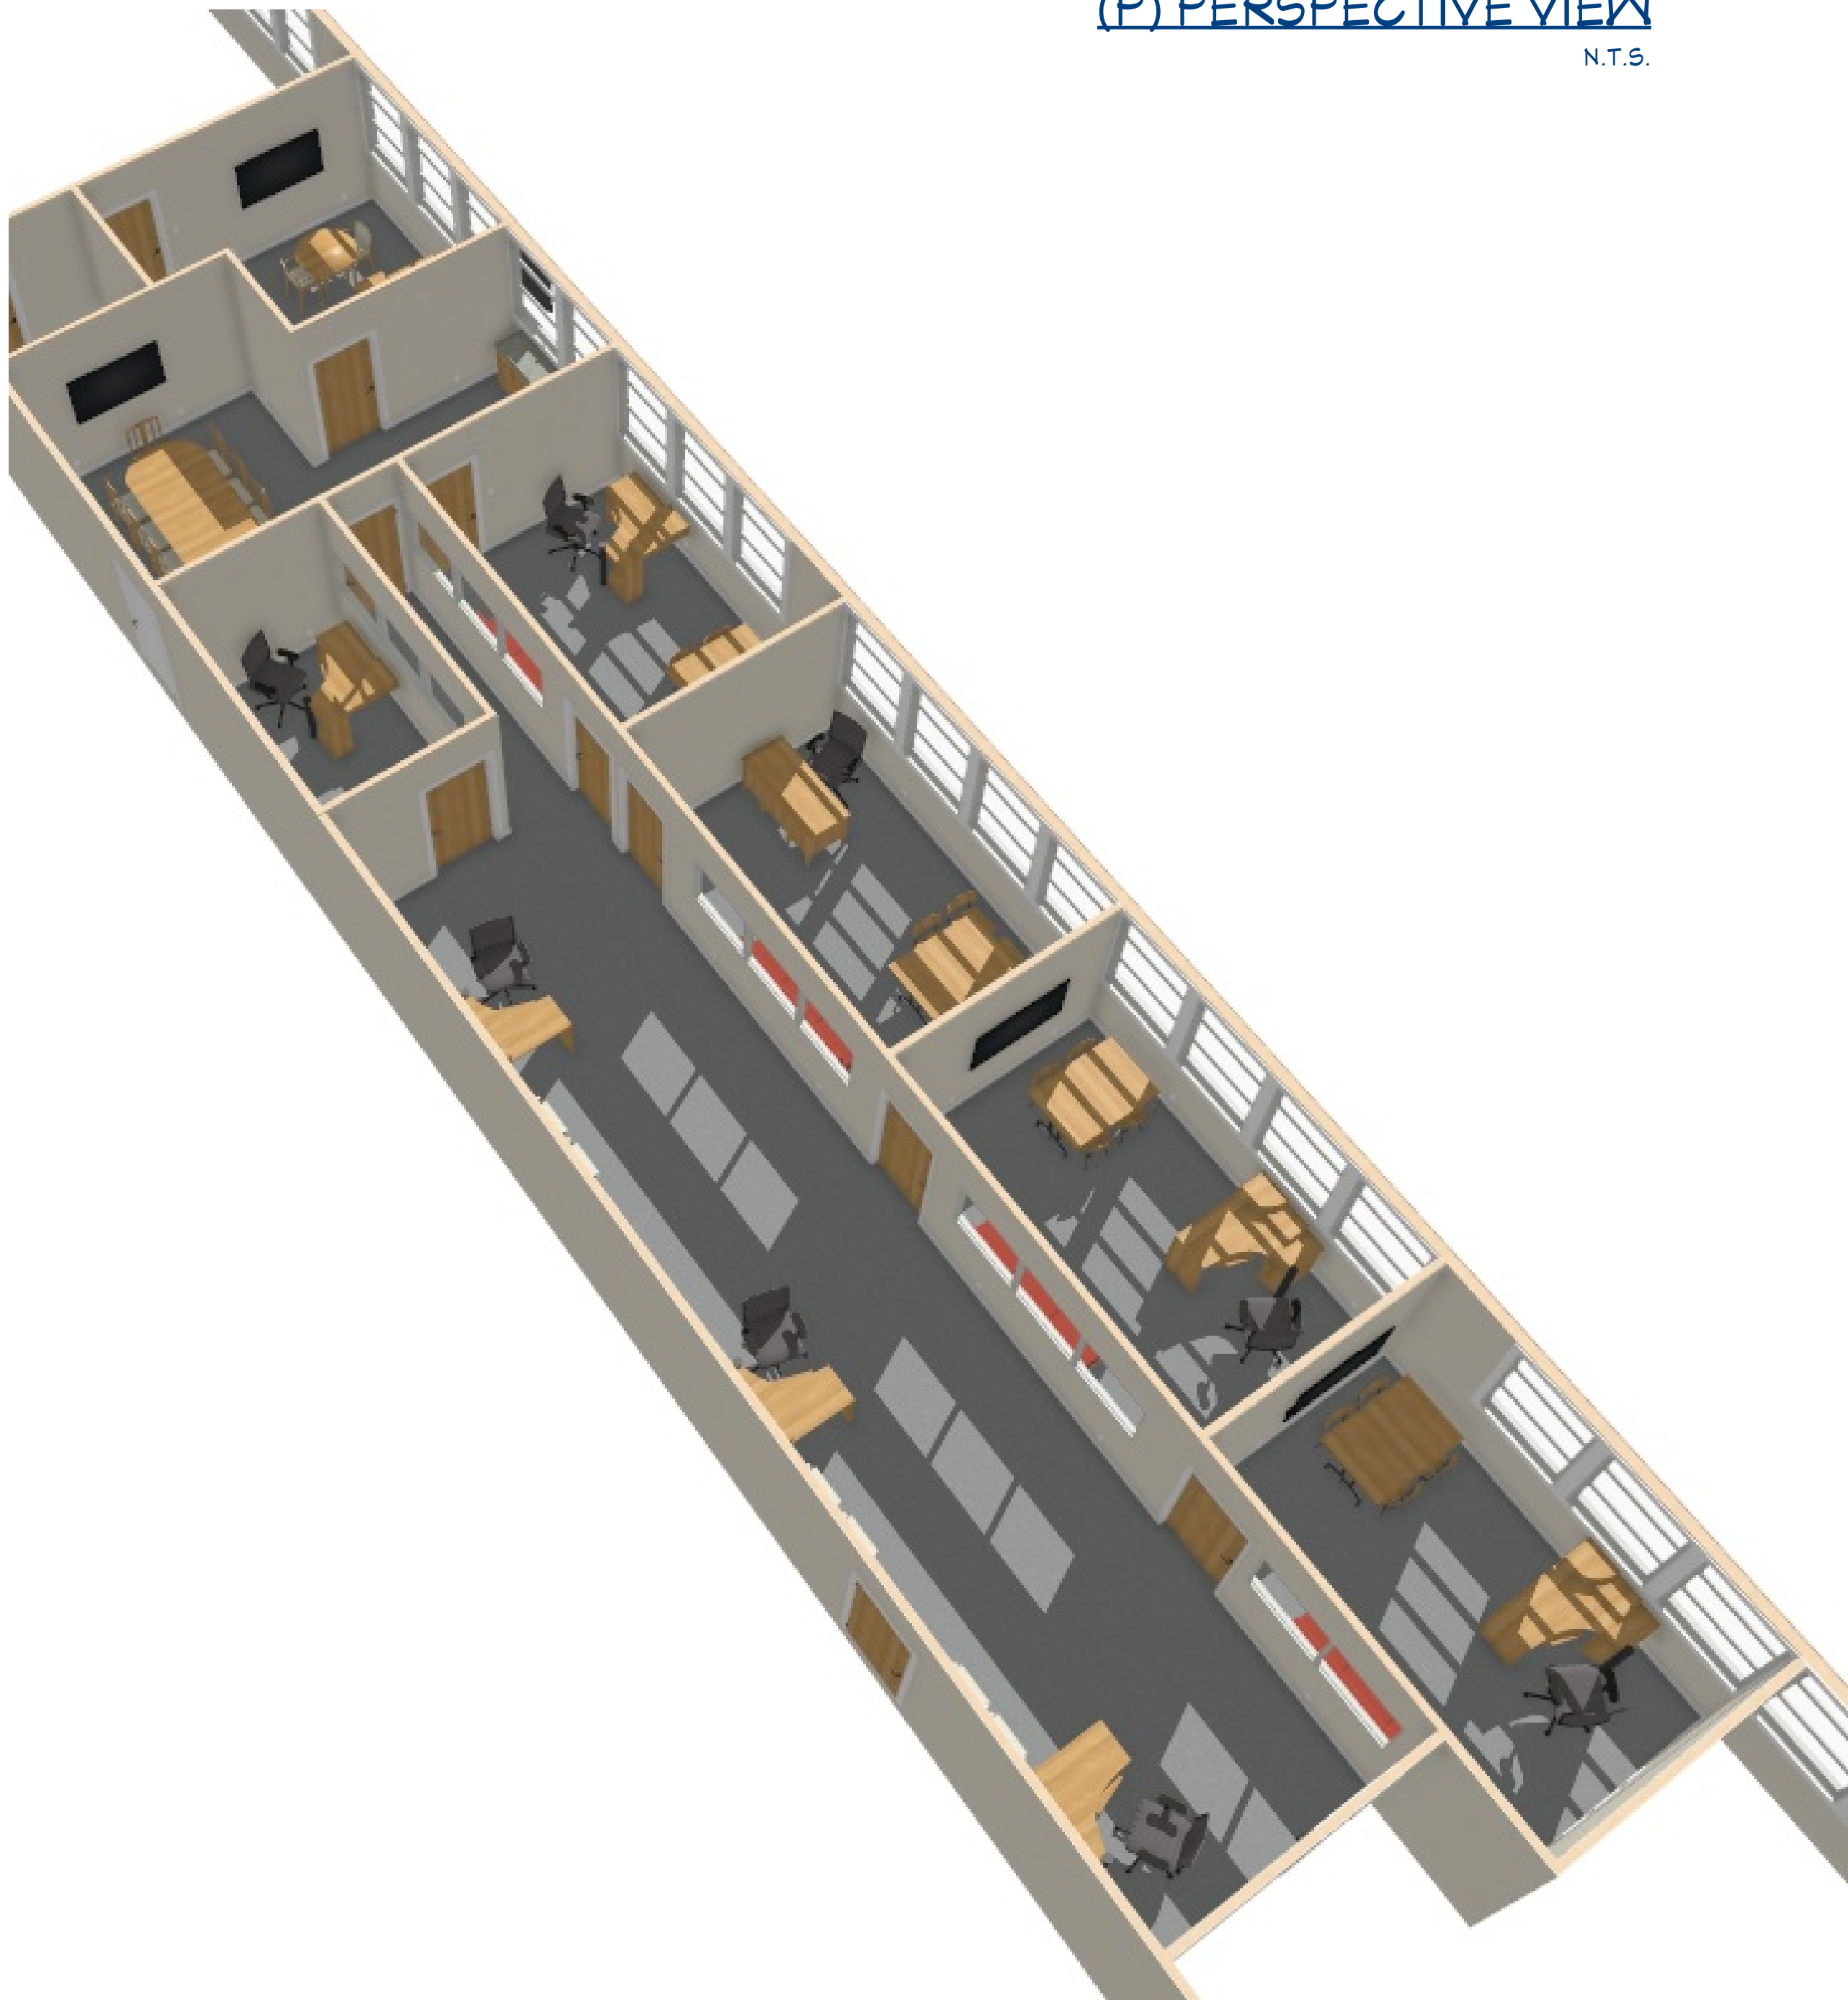

(P) PERSPECTIVE VIEW
N.T.S.

REVISION TABLE	
NUMBER	DATE


HUMBOLDT COUNTY OFFICE OF EDUCATION
901 MYRTLE AVE.
EUREKA, CA 95501-1219

Perspective Views

DRAWINGS PROVIDED BY:
TOM HINZ
5928 STOVER ROAD
BLUE LAKE, CA 95525
PHONE: 707-418-0134
EMAIL: thinz@gmail.com

SCALE @ 24" X 36"

REVISIONS	NO.

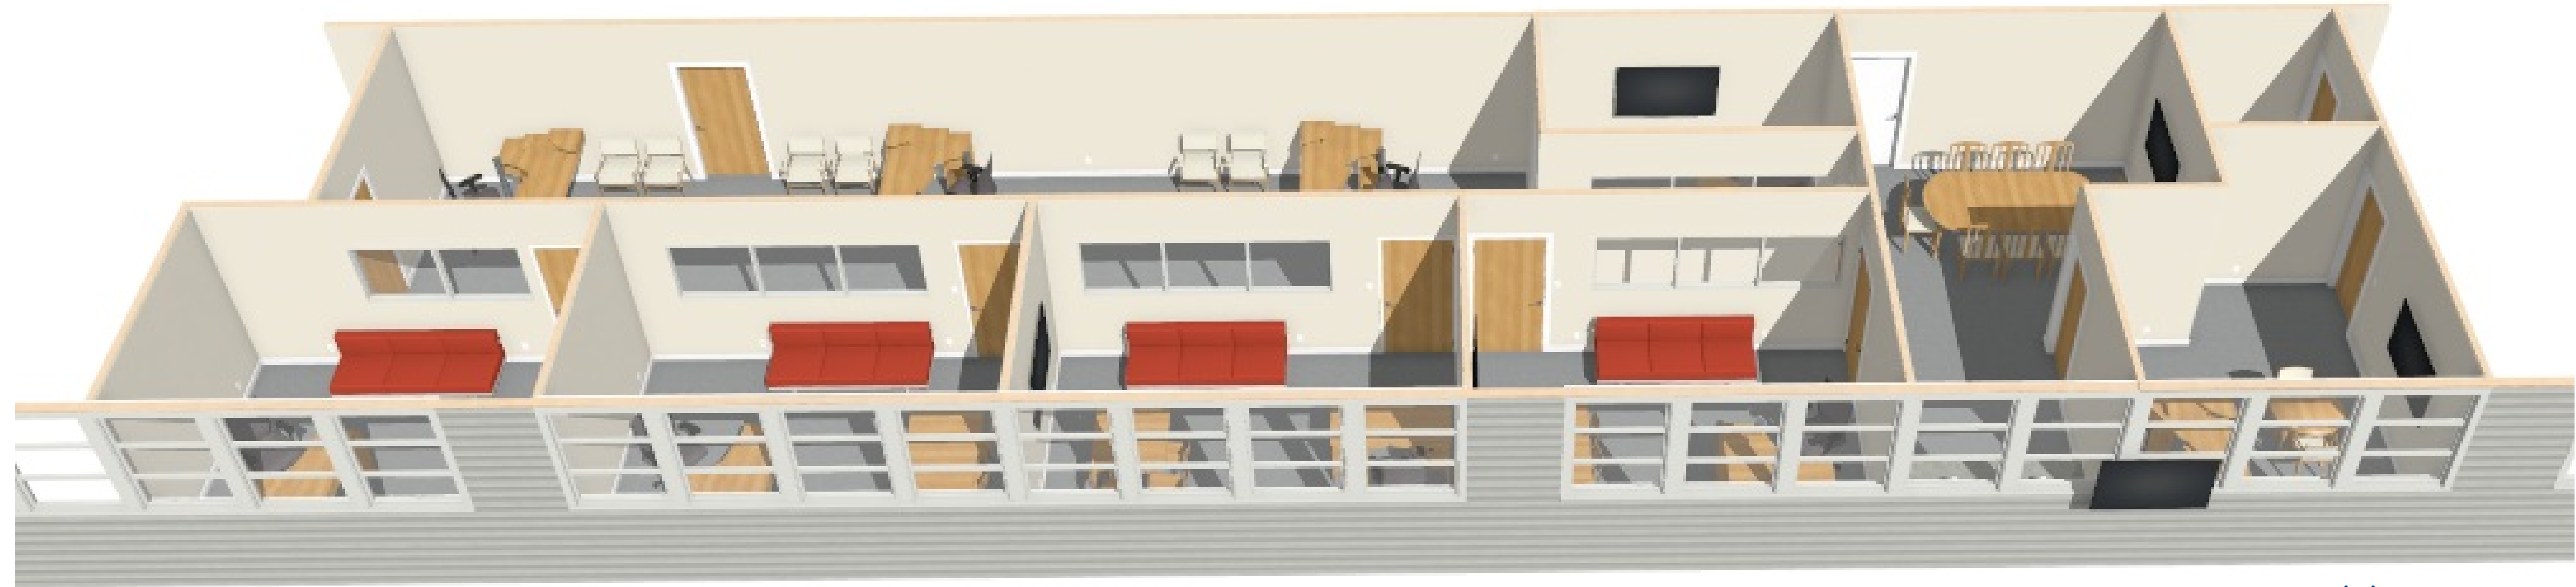

(P) PERSPECTIVE VIEW
N.T.S.



(P) PERSPECTIVE VIEW
N.T.S.



(P) PERSPECTIVE VIEW
N.T.S.

REVISION TABLE		
NUMBER	DATE	DESCRIPTION

HUMBOLDT COUNTY OFFICE OF EDUCATION
901 MYRTLE AVE.
EUREKA, CA 95501-1219

Perspective Views

DRAWINGS PROVIDED BY:
TOM HINZ
5928 STOVER ROAD
BLUE LAKE, CA 95525
PHONE: 707-418-0134
EMAIL: thinz@gmail.com

SCALE @ 24" X 36"

REVISIONS	NO.